
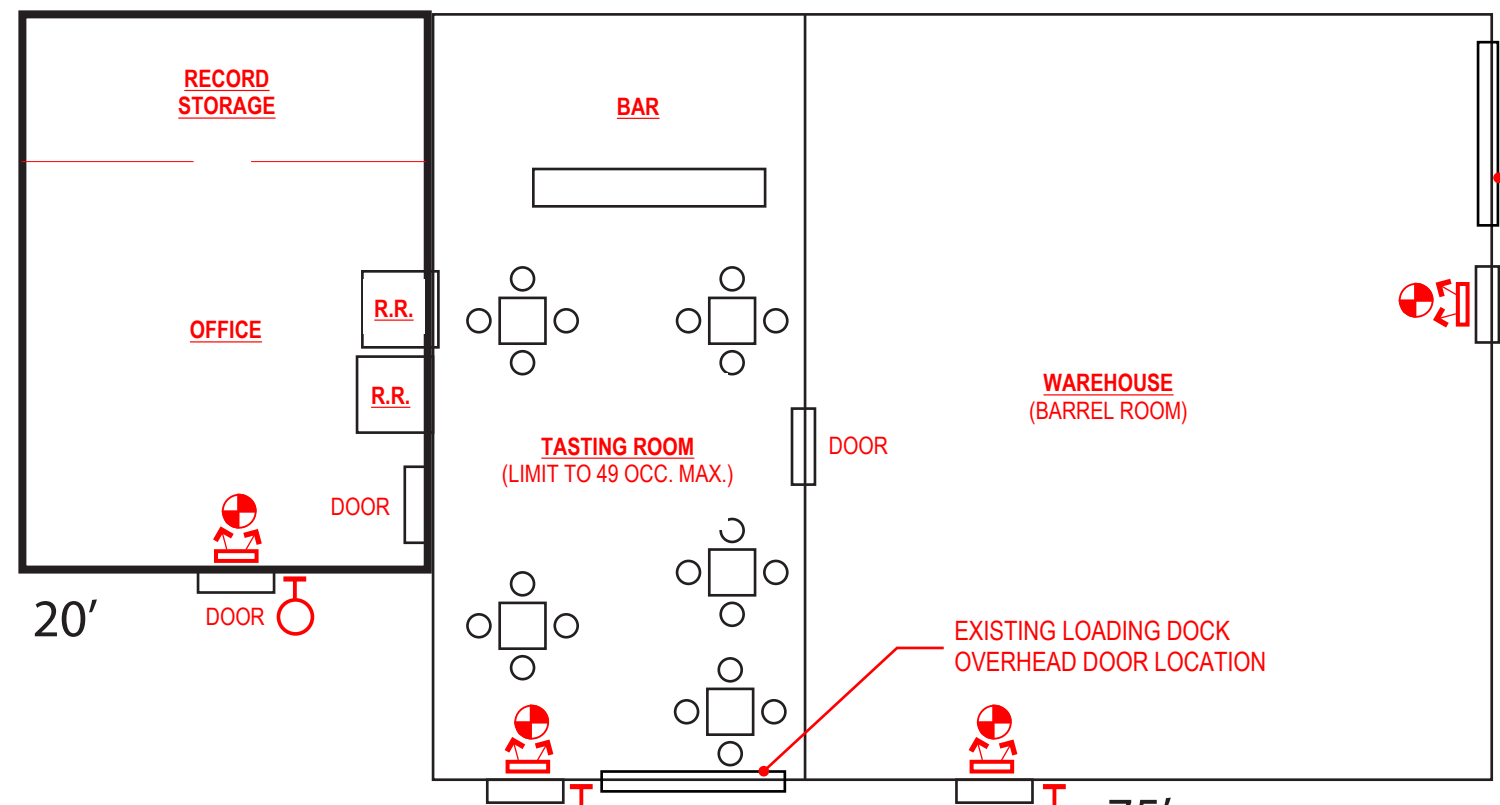


IRONTON DISTILLERY

1303 EMPIRE ROAD LOUISVILLE, CO 80027

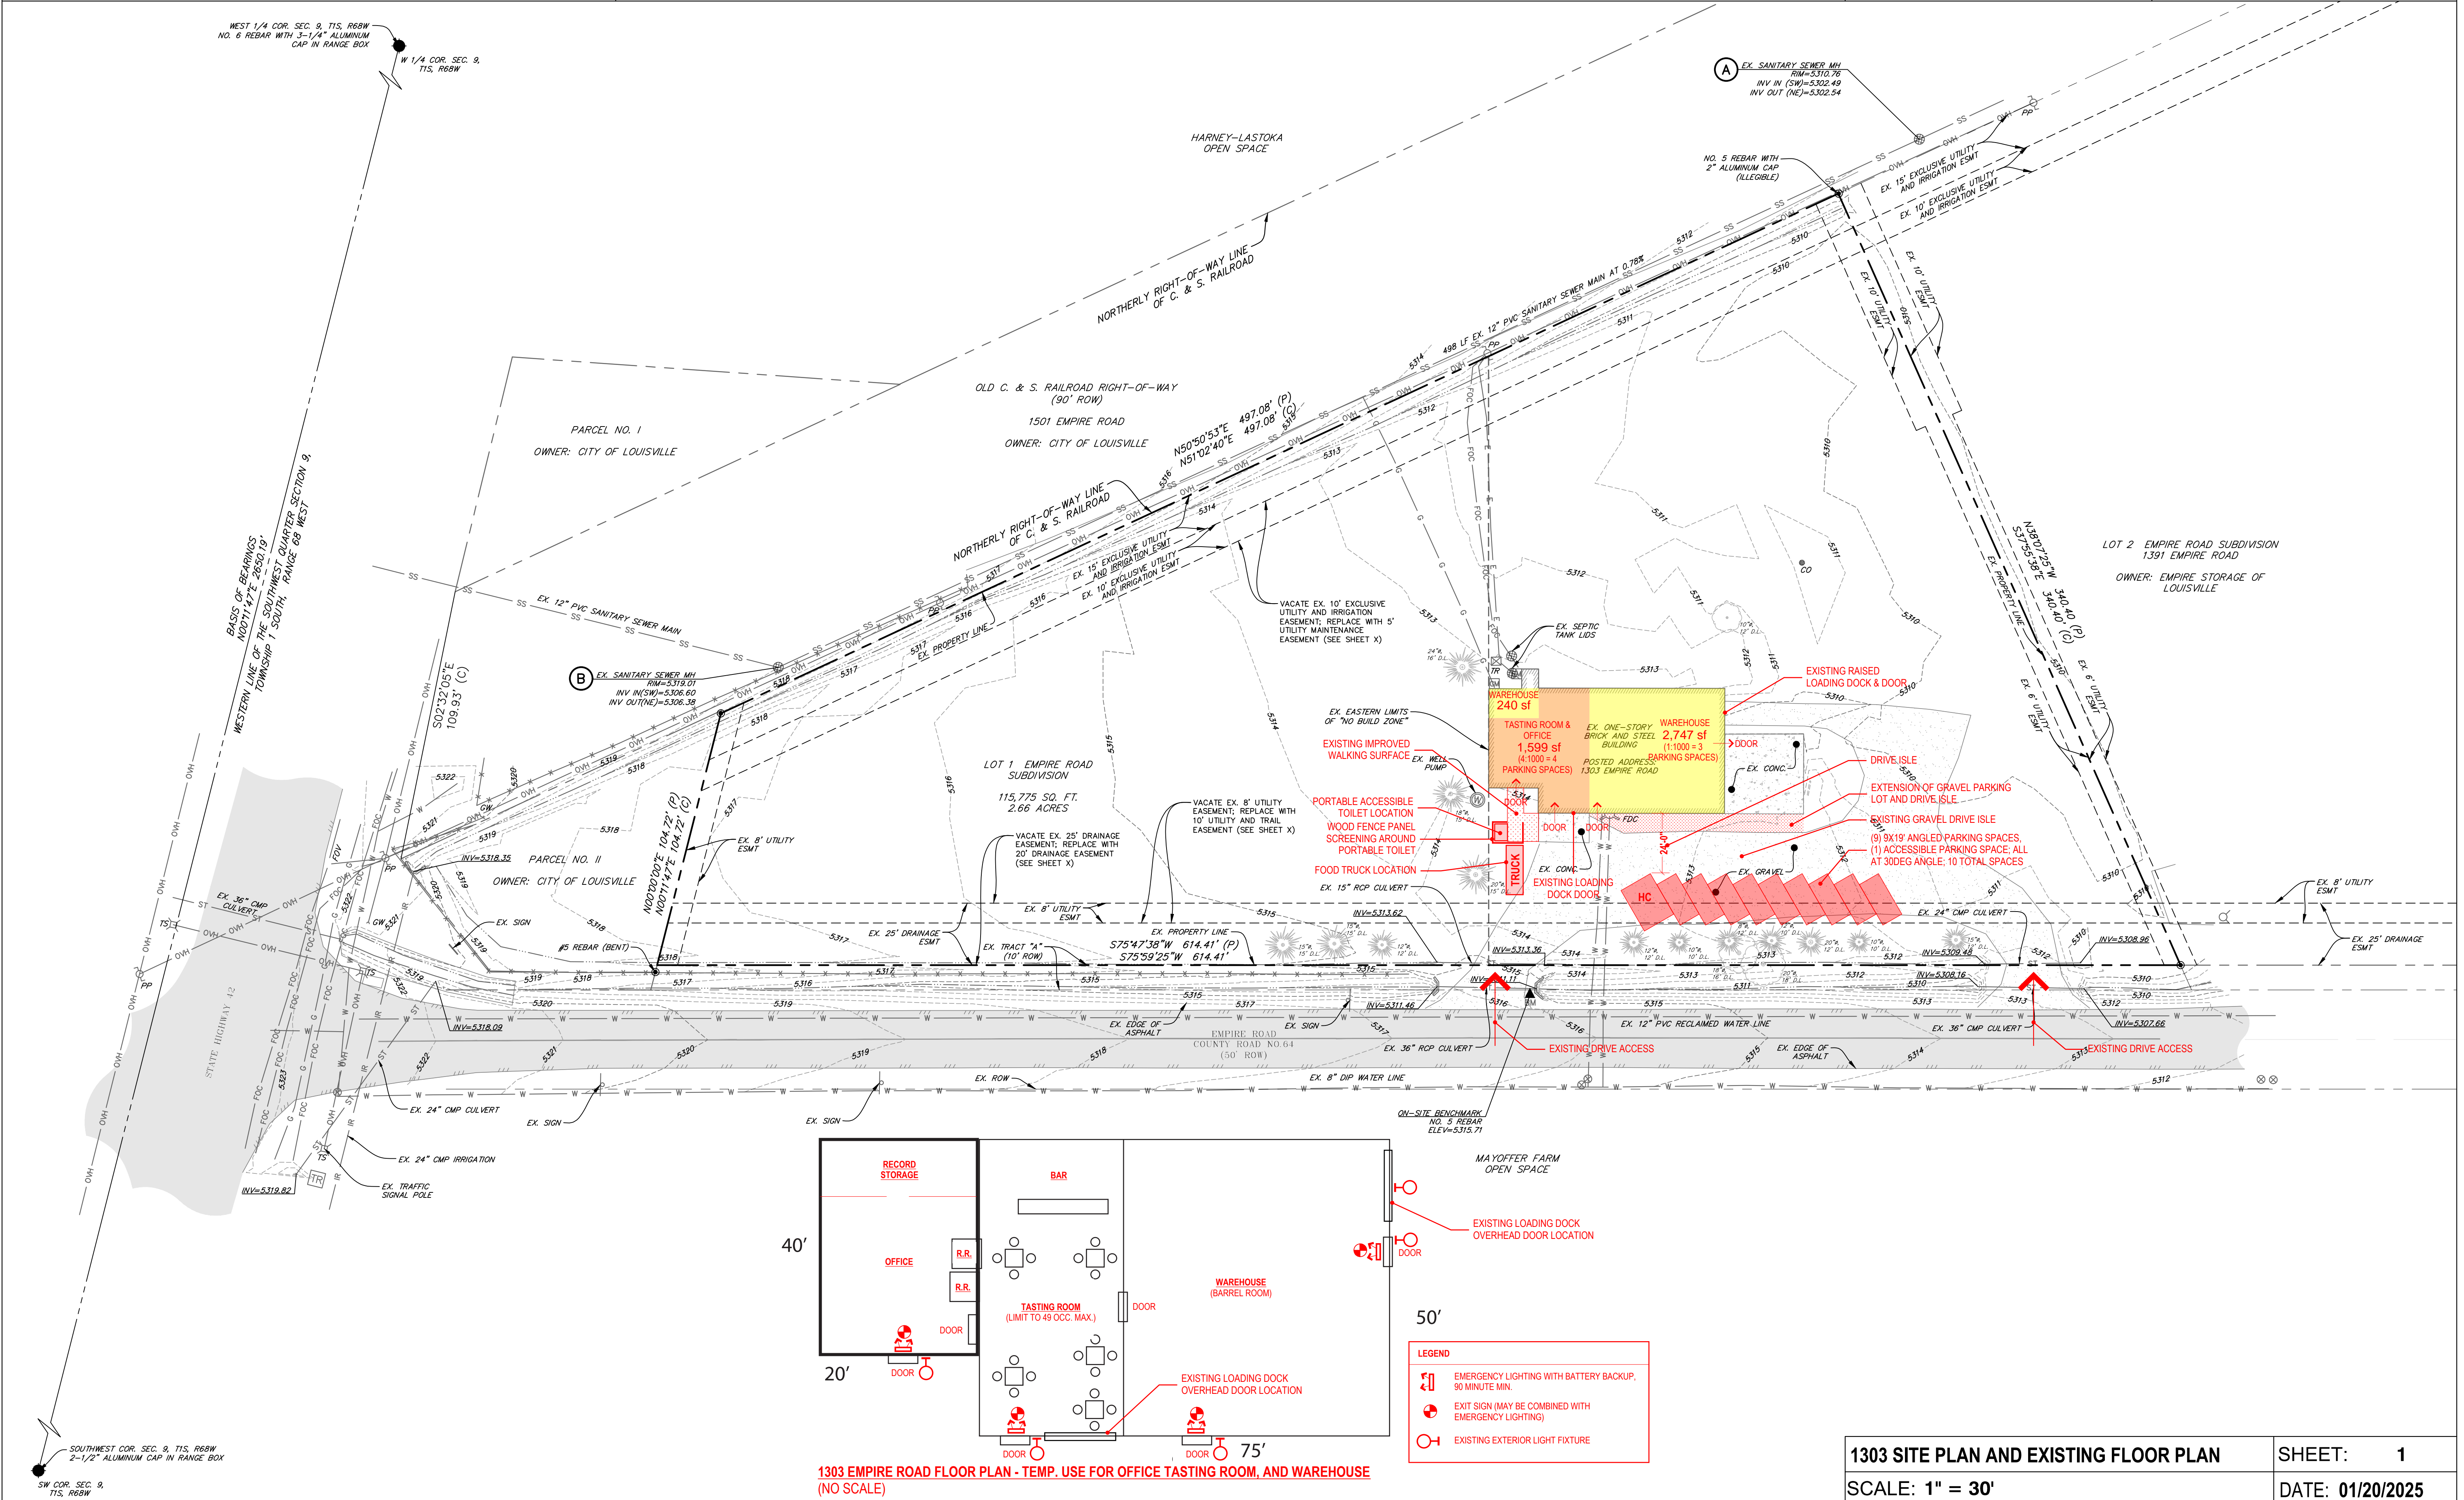

- LEGEND**
- EMERGENCY LIGHTING WITH BATTERY BACKUP, 90 MINUTE MIN.
 - EXIT SIGN (MAY BE COMBINED WITH EMERGENCY LIGHTING)
 - EXISTING EXTERIOR LIGHT FIXTURE

1303 EMPIRE ROAD FLOOR PLAN - TEMP. USE FOR OFFICE TASTING ROOM, AND WAREHOUSE (NO SCALE)

1303 SITE PLAN AND EXISTING FLOOR PLAN	SHEET: 1
SCALE: 1" = 30'	DATE: 01/20/2025